


Notes:

DO NOT SCALE DIMENSIONS FROM THIS DRAWING
ALL DIMENSIONS TO BE VERIFIED ON SITE.

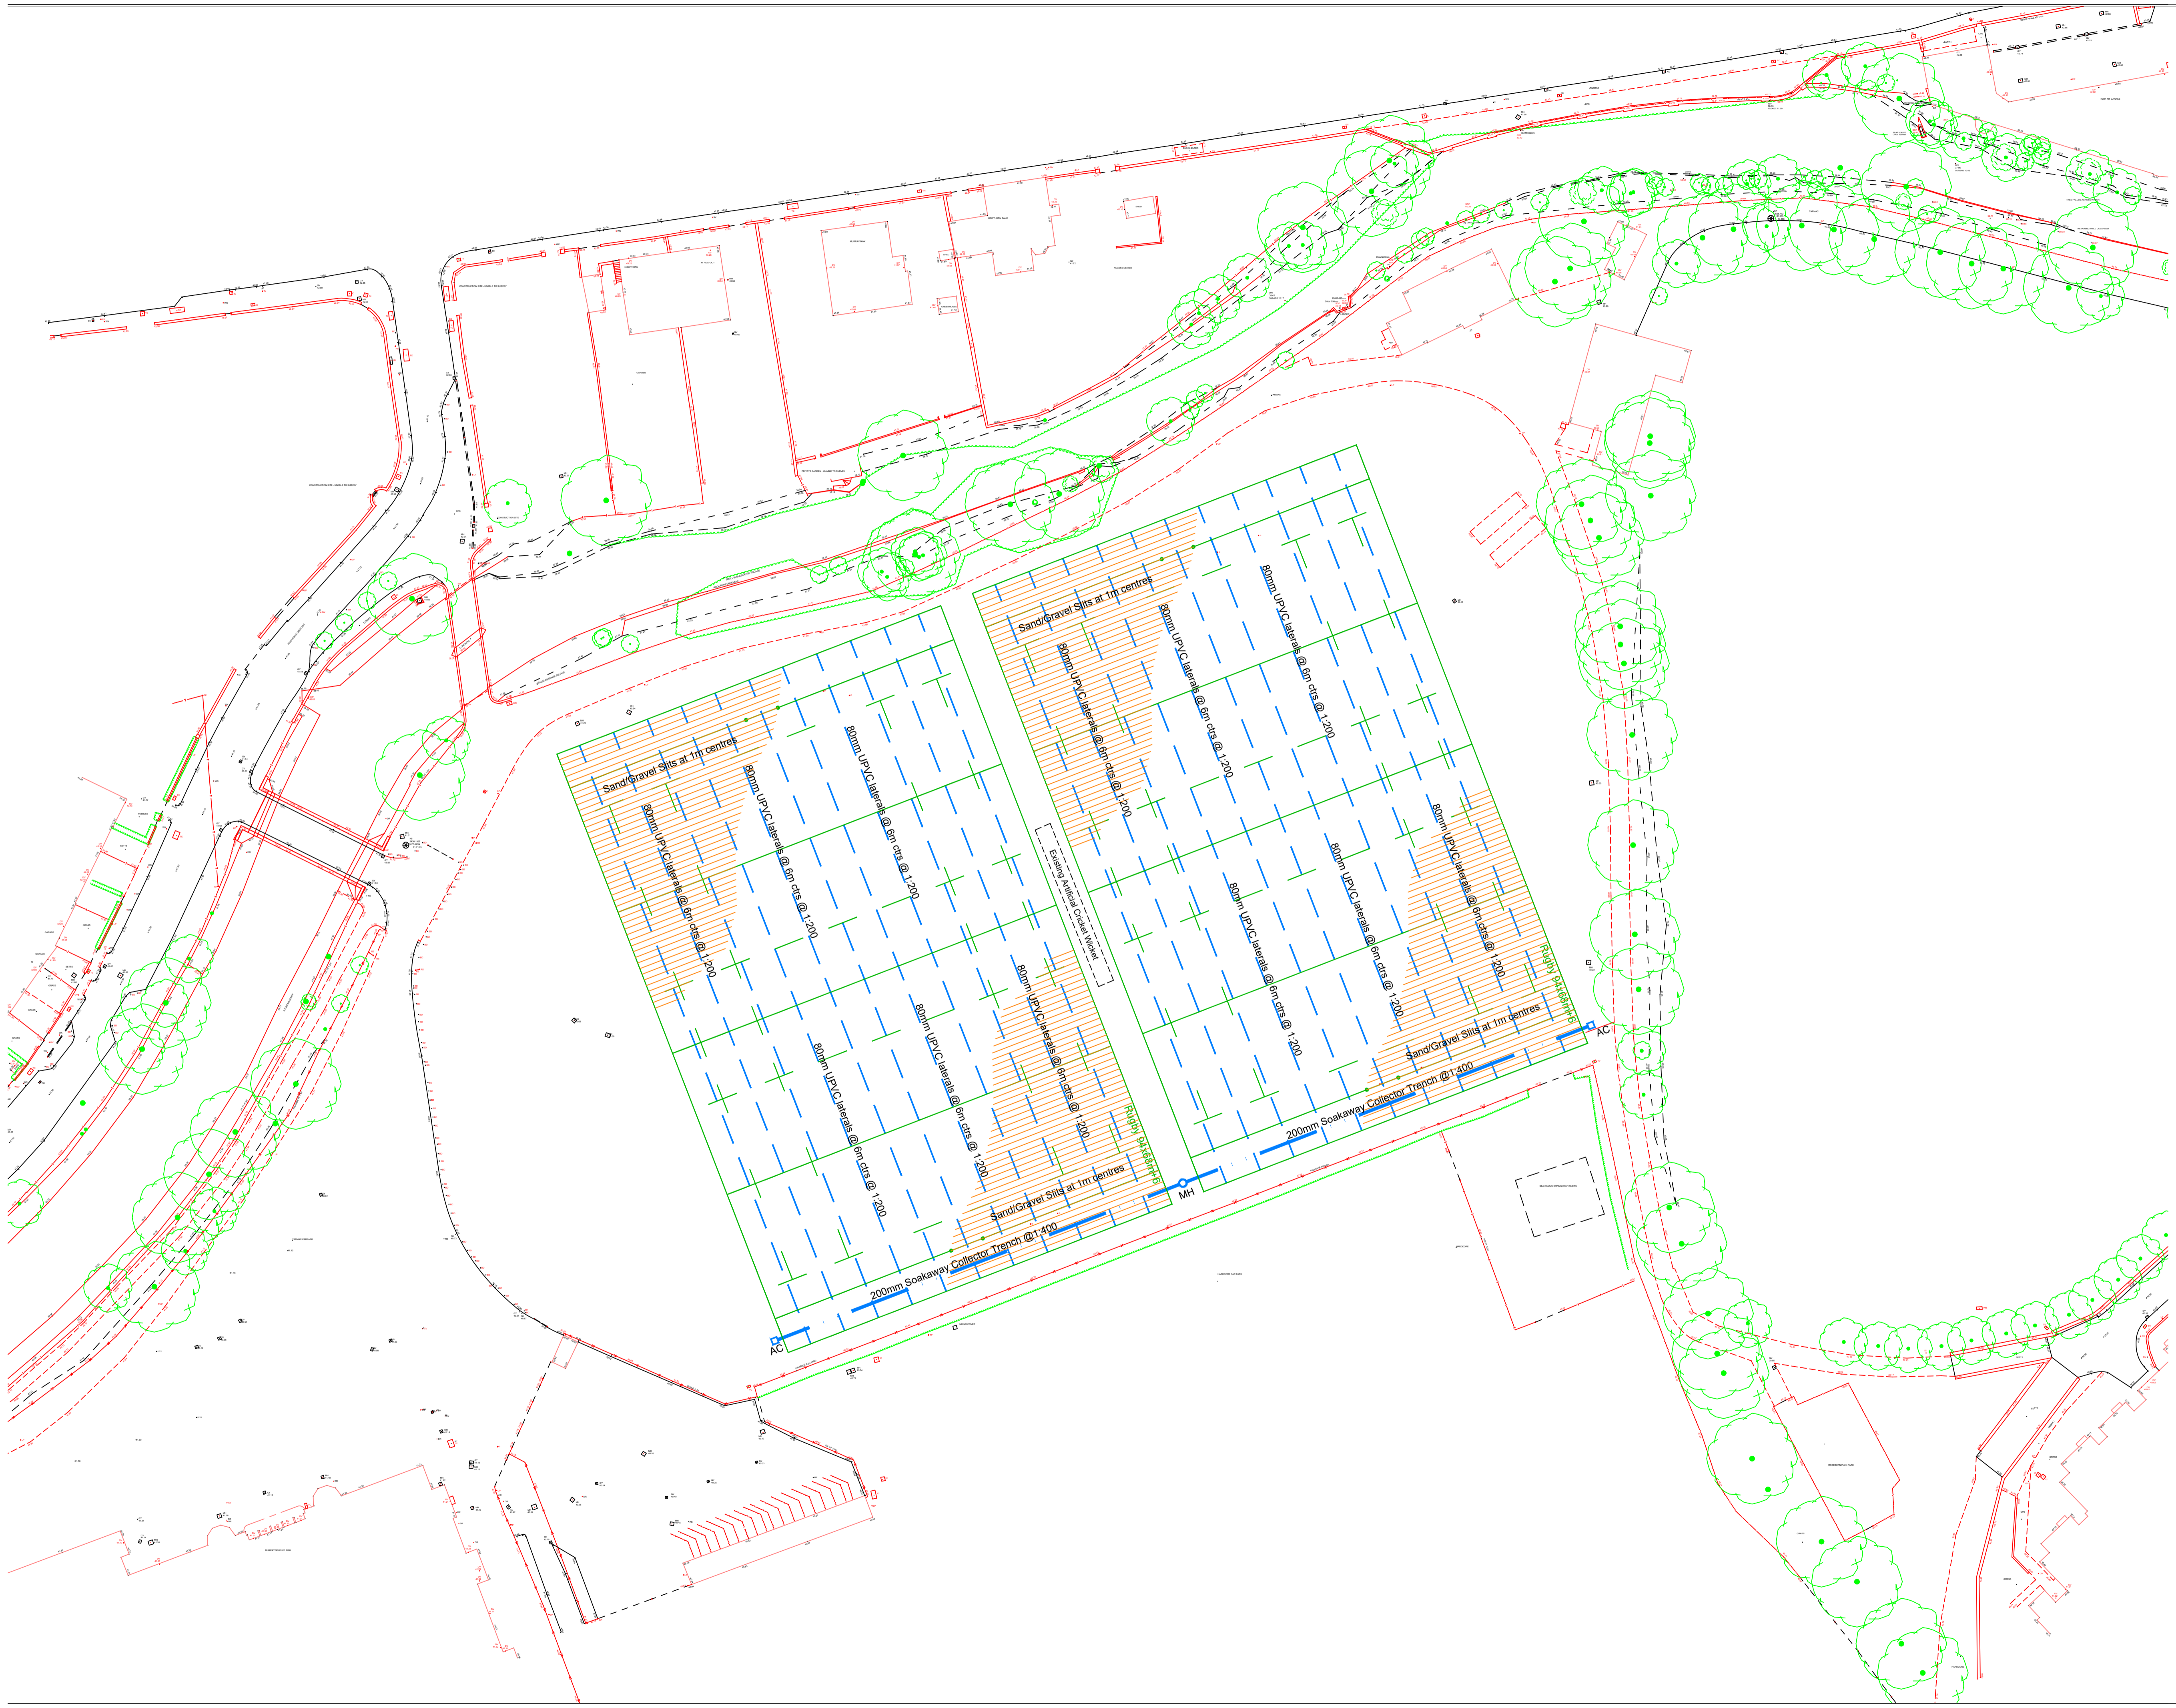

REVISION

rev.	date	details	drwn	chkd

TENDER

PSD Professional Sportsturf Design
6 Crosshill Drive, Glasgow, G73 3QU
Tel: 0141 643 1298 Fax: 0141 647 8022
email: office@psdscotland.co.uk

Client:
MURRAYFIELD WANDERERS RFC

Project Title:
ROSEBURN PARK
MURRAYFIELD, EDINBURGH
UPGRADE OF NATURAL GRASS PITCHES

Drawing Title:
DRAINAGE LAYOUT

Scale @ A1: 1:500 Drawn by: WGG Date: May 19 Checked by:

Drawing No:
MWRFC/104